



REFER TO ENGINEERS DRAWINGS FOR ALL
PROPOSED ROAD AND FOOTPATH LAYOUTS AND
DETAILS

REFER TO LANDSCAPE ARCHITECTS DRAWING FOR
ALL LANDSCAPING DETAILS

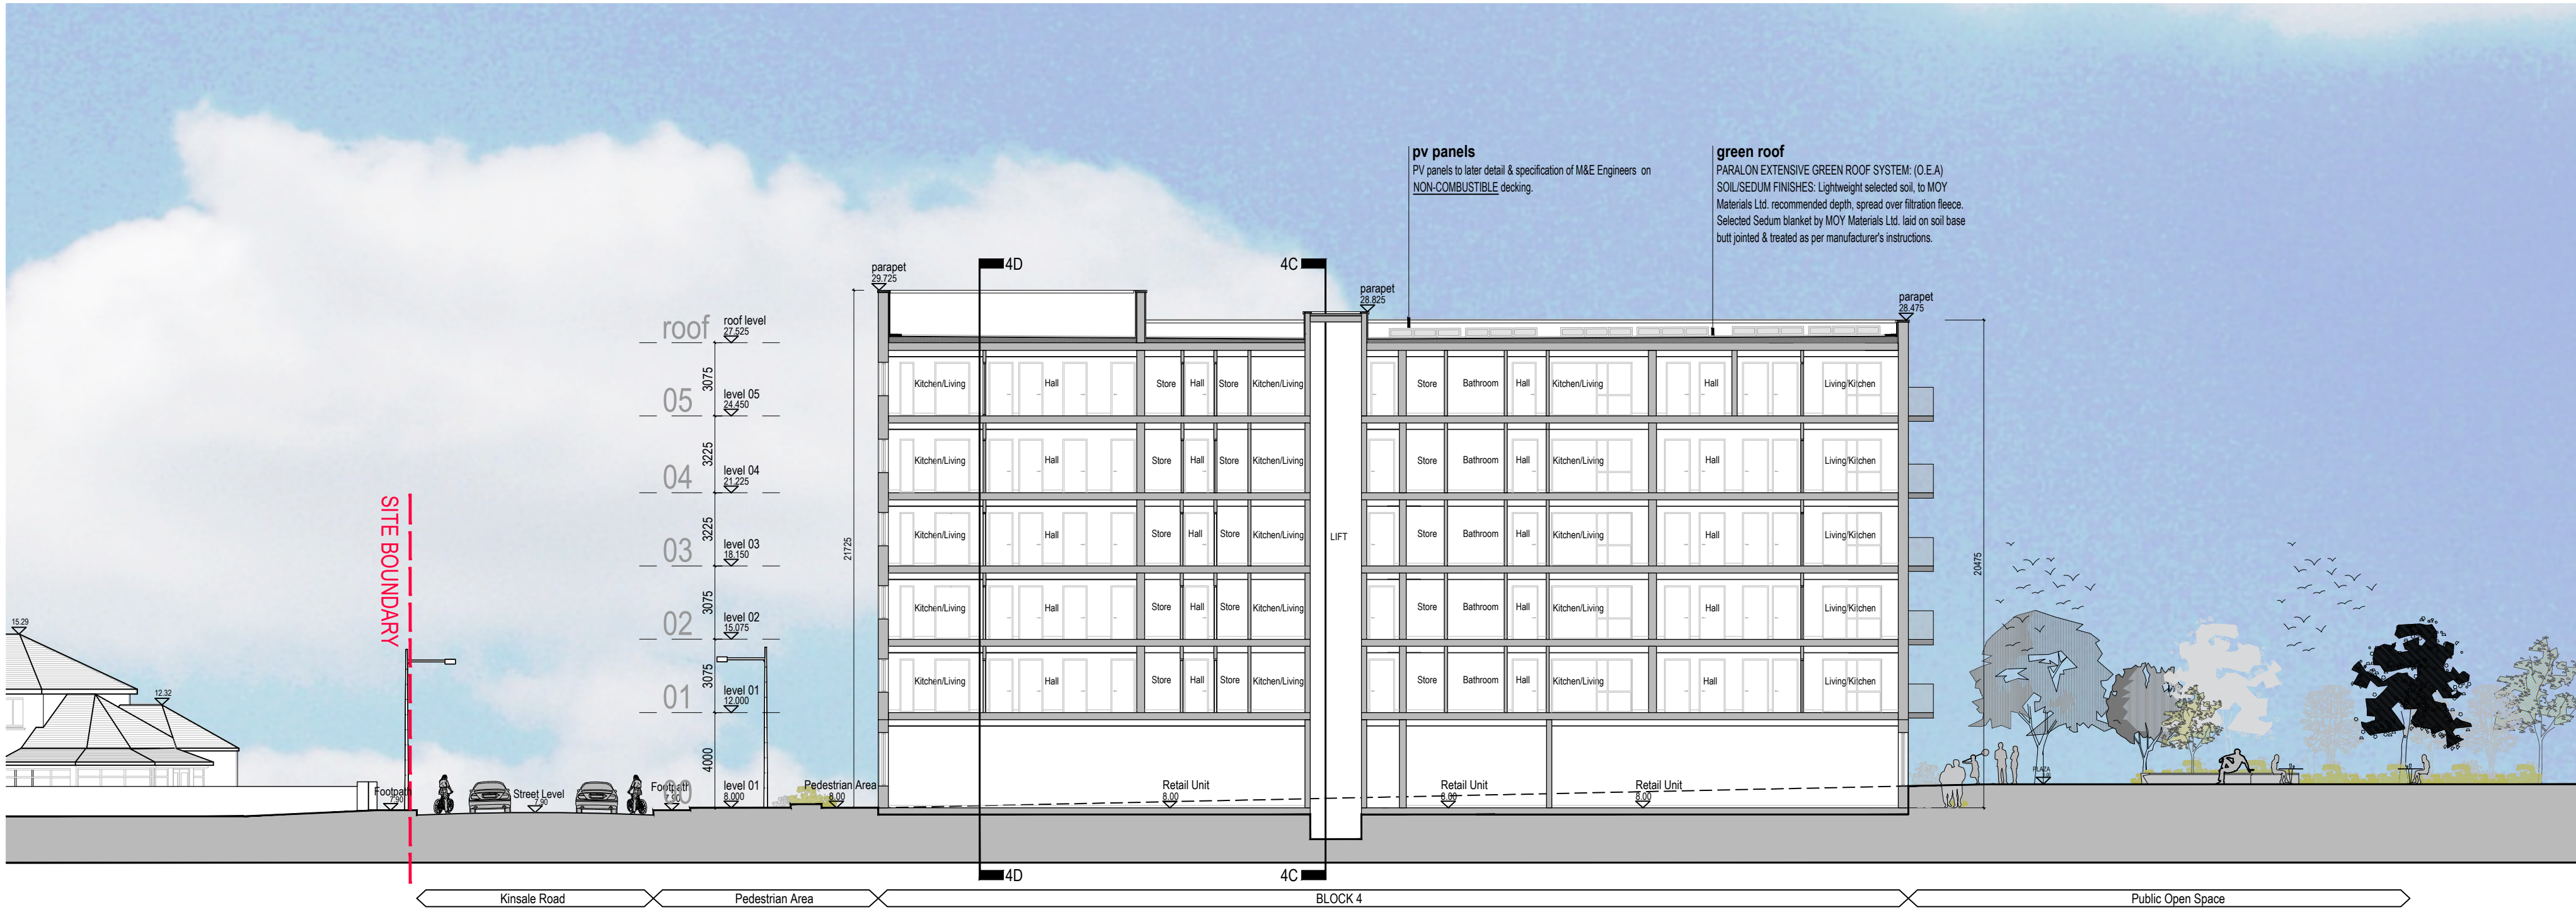


01 Block 4 SECTION 4-A
1:200

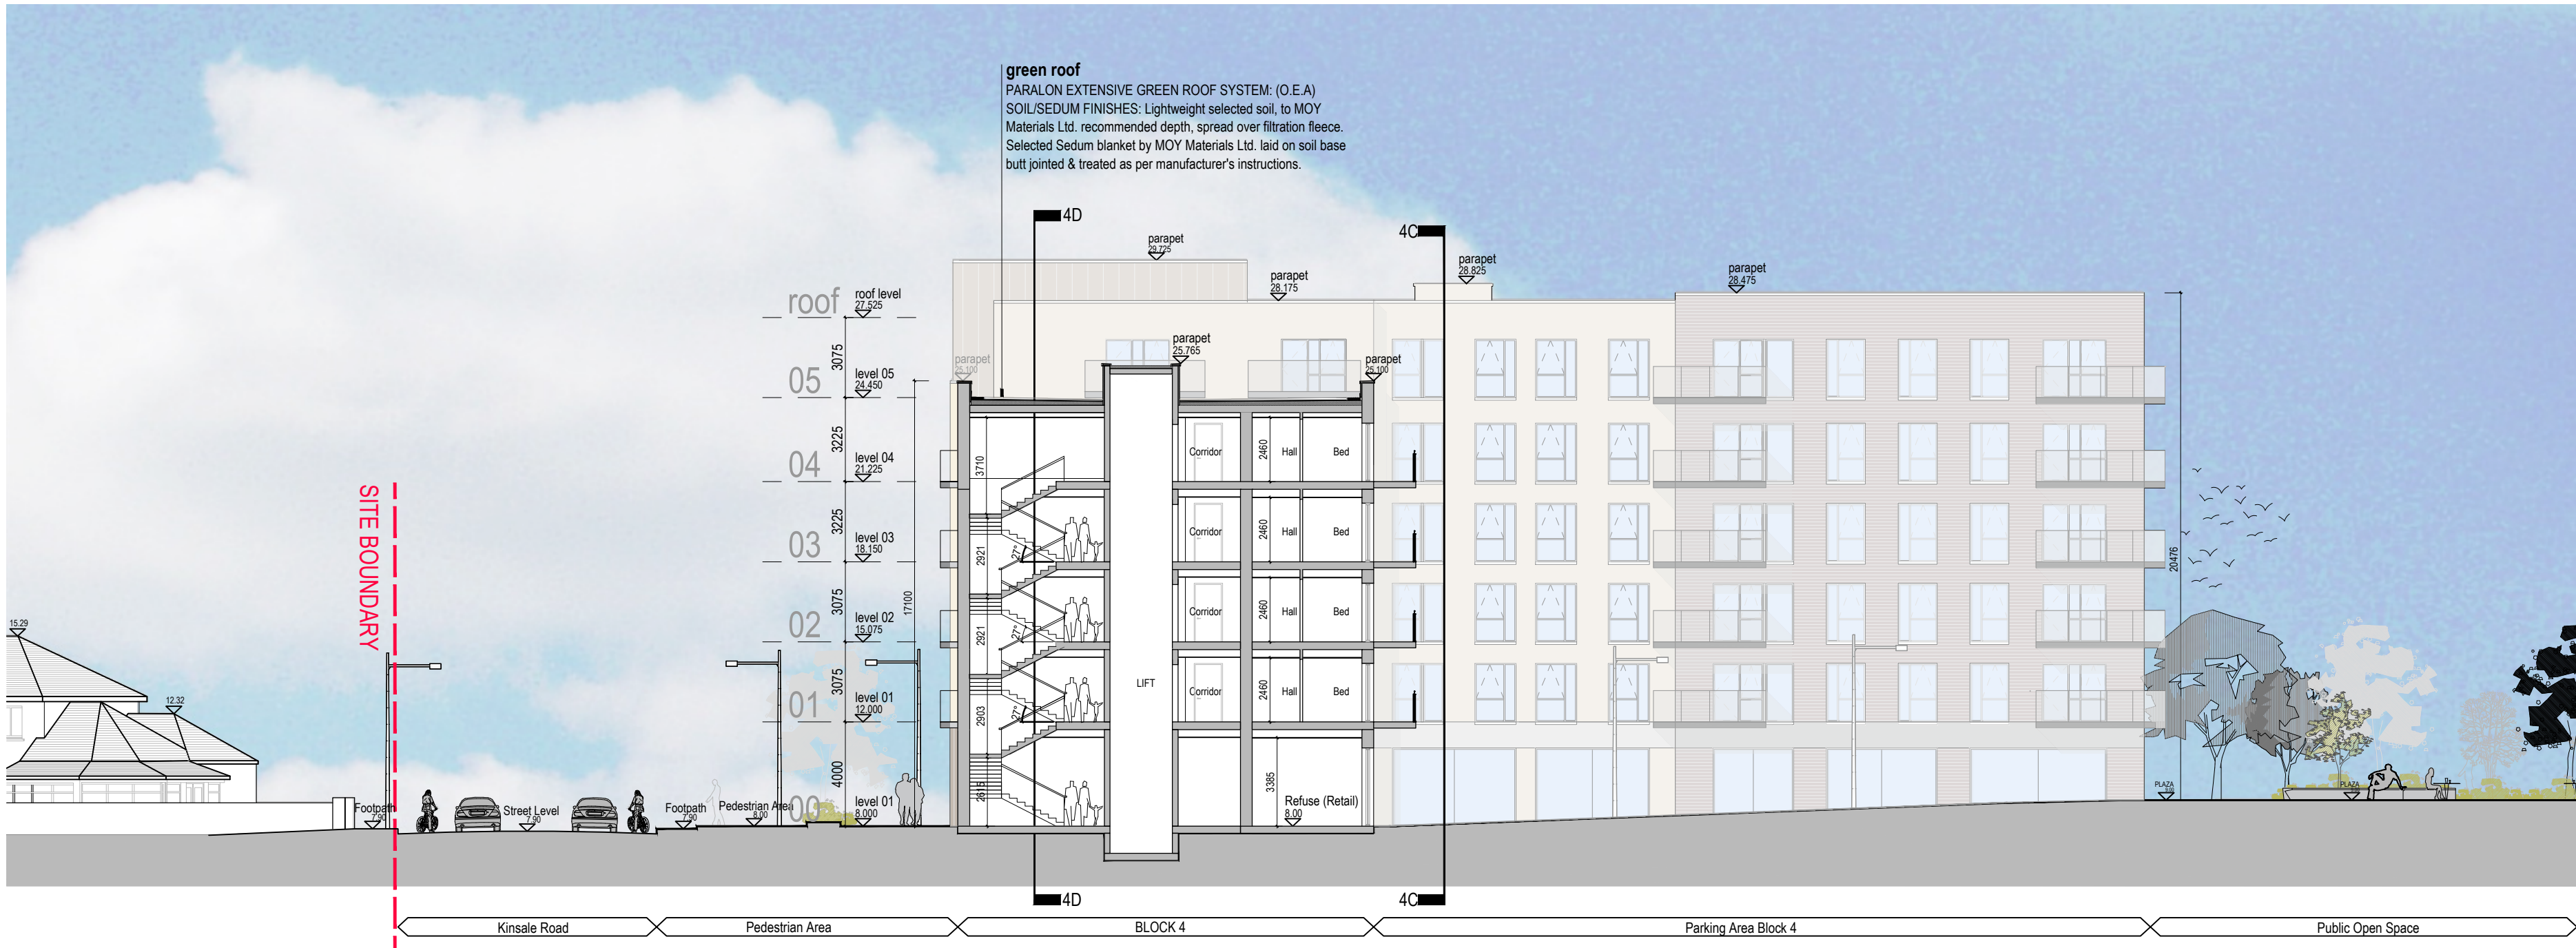

02 Block 4 SECTION 4-B
1:200



KEY PLAN 1:500

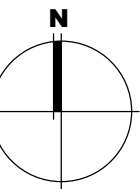

Block 4 Sections

Notes					No.	Date	Revision	Initials
1. Copyright Reserved					E	03.04.2023	General update to Sections	DK
2. Work to figured dimensions only. Do not scale drawing.								
3. The contractor is responsible for checking all levels and dimensions on site and shall refer all discrepancies to the Architect								
4. Where appropriate, for details of r.c. structure, or mechanical and electrical details, see Engineers drawings								
5. Proprietary items shall be fixed in strict accordance with manufacturer's instructions.								
6. Sizes of proprietary items shall be checked with manufacturer.								
7. The contractor shall be responsible for the coordination of structure, finishes and services.								
8. For further information, refer to the project information sheet (PIS) and the Planning Application(2) CAD Drawings(3) Sections/BL								
KRC-BKD-04-ZZ-DR-A-3000.dwg 04/04/2025 11:51:11								

Issue Status								
Progress								
Planning Application								
Fire Cert								
Disability Cert								
Tender								
Construction								
As Built								
Information Only								

Kinsale Road LRD									
Drawing Title Block 4 Sections									
Stage	Planning	Scale	1:200 @A1	Drawn	AA	Appt	MD	Date	25.08.24
Project Code	6284	job	KRC	origin	BKD	zone	04	level	ZZ
						type	DR	ds	A-
						sheet no.	3000	status	P3.4
								rev	E

bkdarchitects
BUNRAVEN ROAD, DUBLIN 12
2ND FLOOR EUROPA HOUSE, HARCOURT CENTRE, HARCOURT ST. DUBLIN 02
002 WICK, IRELAND - EMAIL: ARCHITECTURE@BKD.IE - PH:01 616 2400 - W: WWW.BKD.IE