



REFER TO ENGINEERS DRAWINGS FOR ALL
PROPOSED ROAD AND FOOTPATH LAYOUTS AND
DETAILS

REFER TO LANDSCAPE ARCHITECTS DRAWING FOR
ALL LANDSCAPING DETAILS

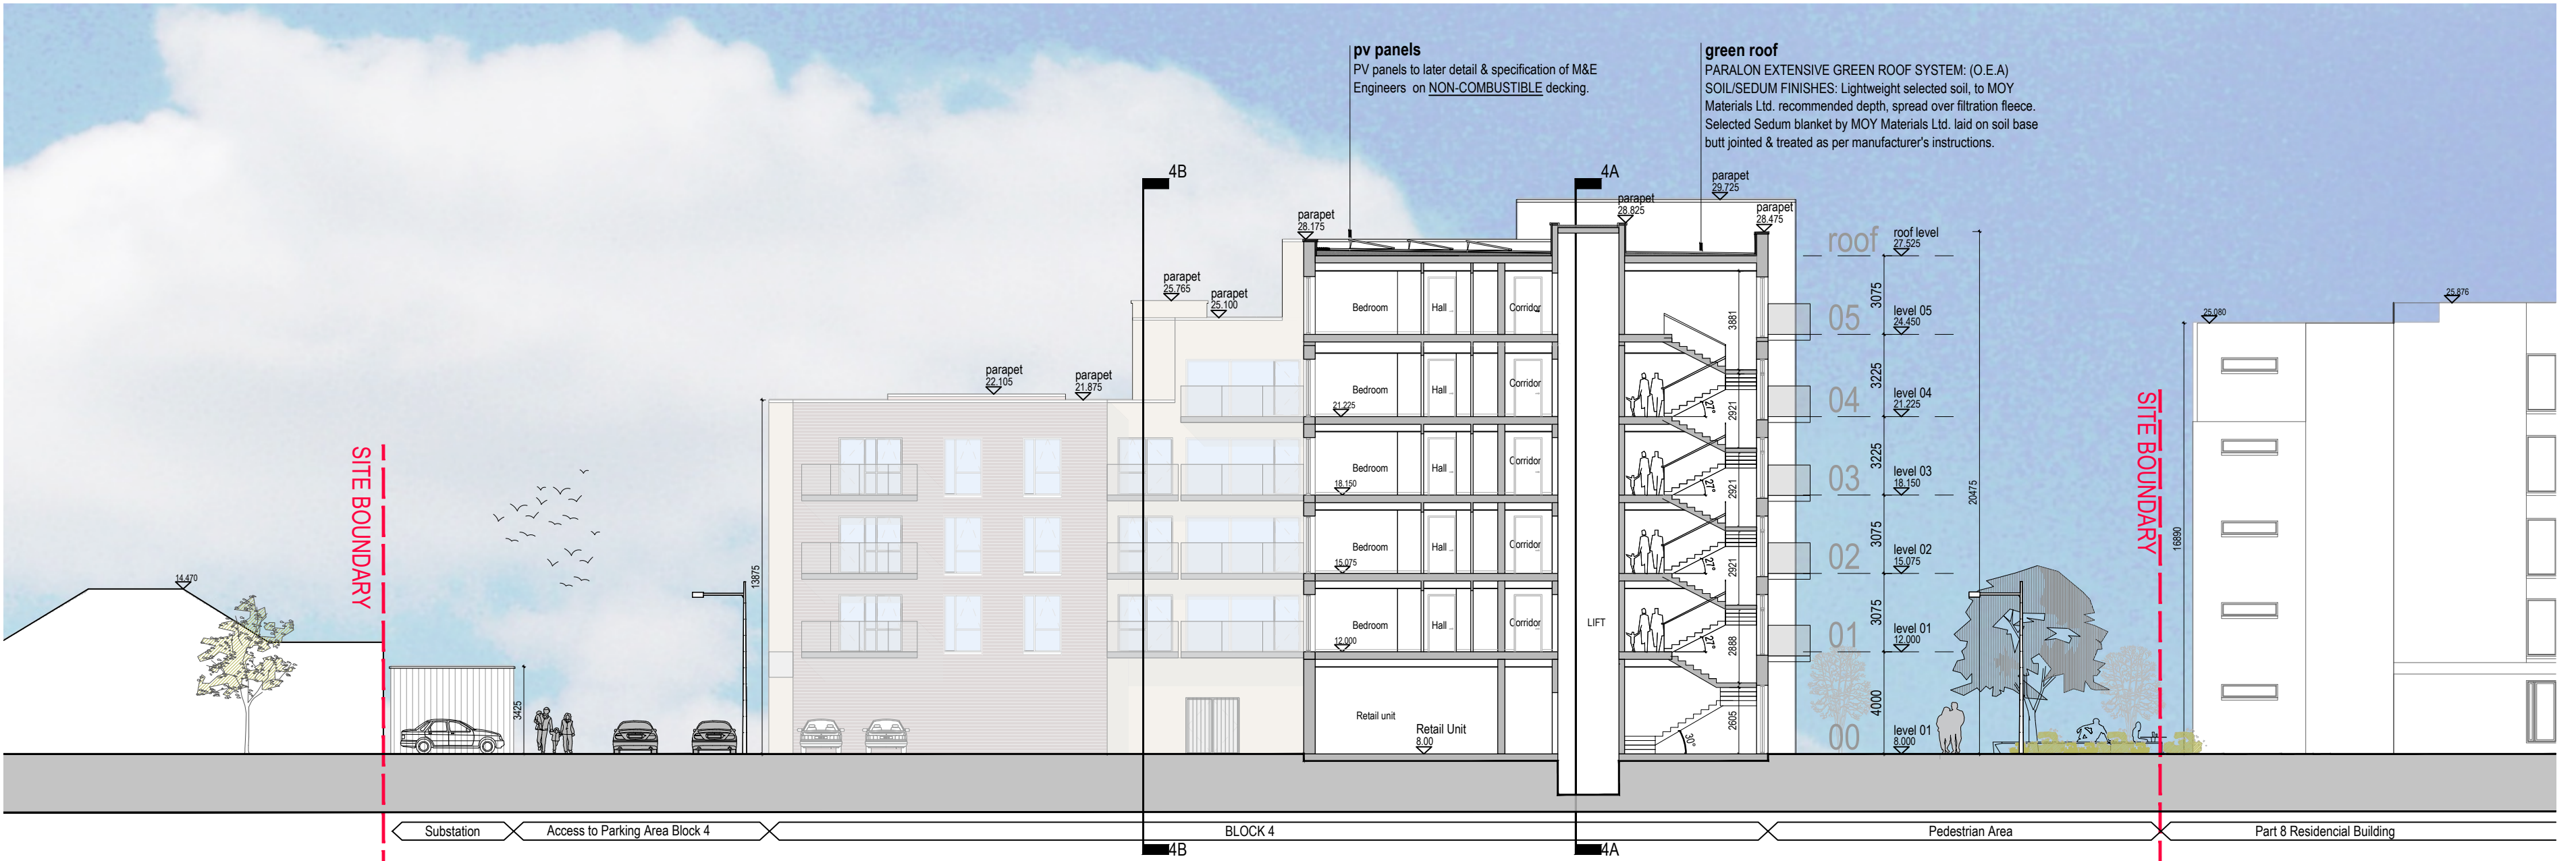

03 Block 4 SECTION 4-C
1:200

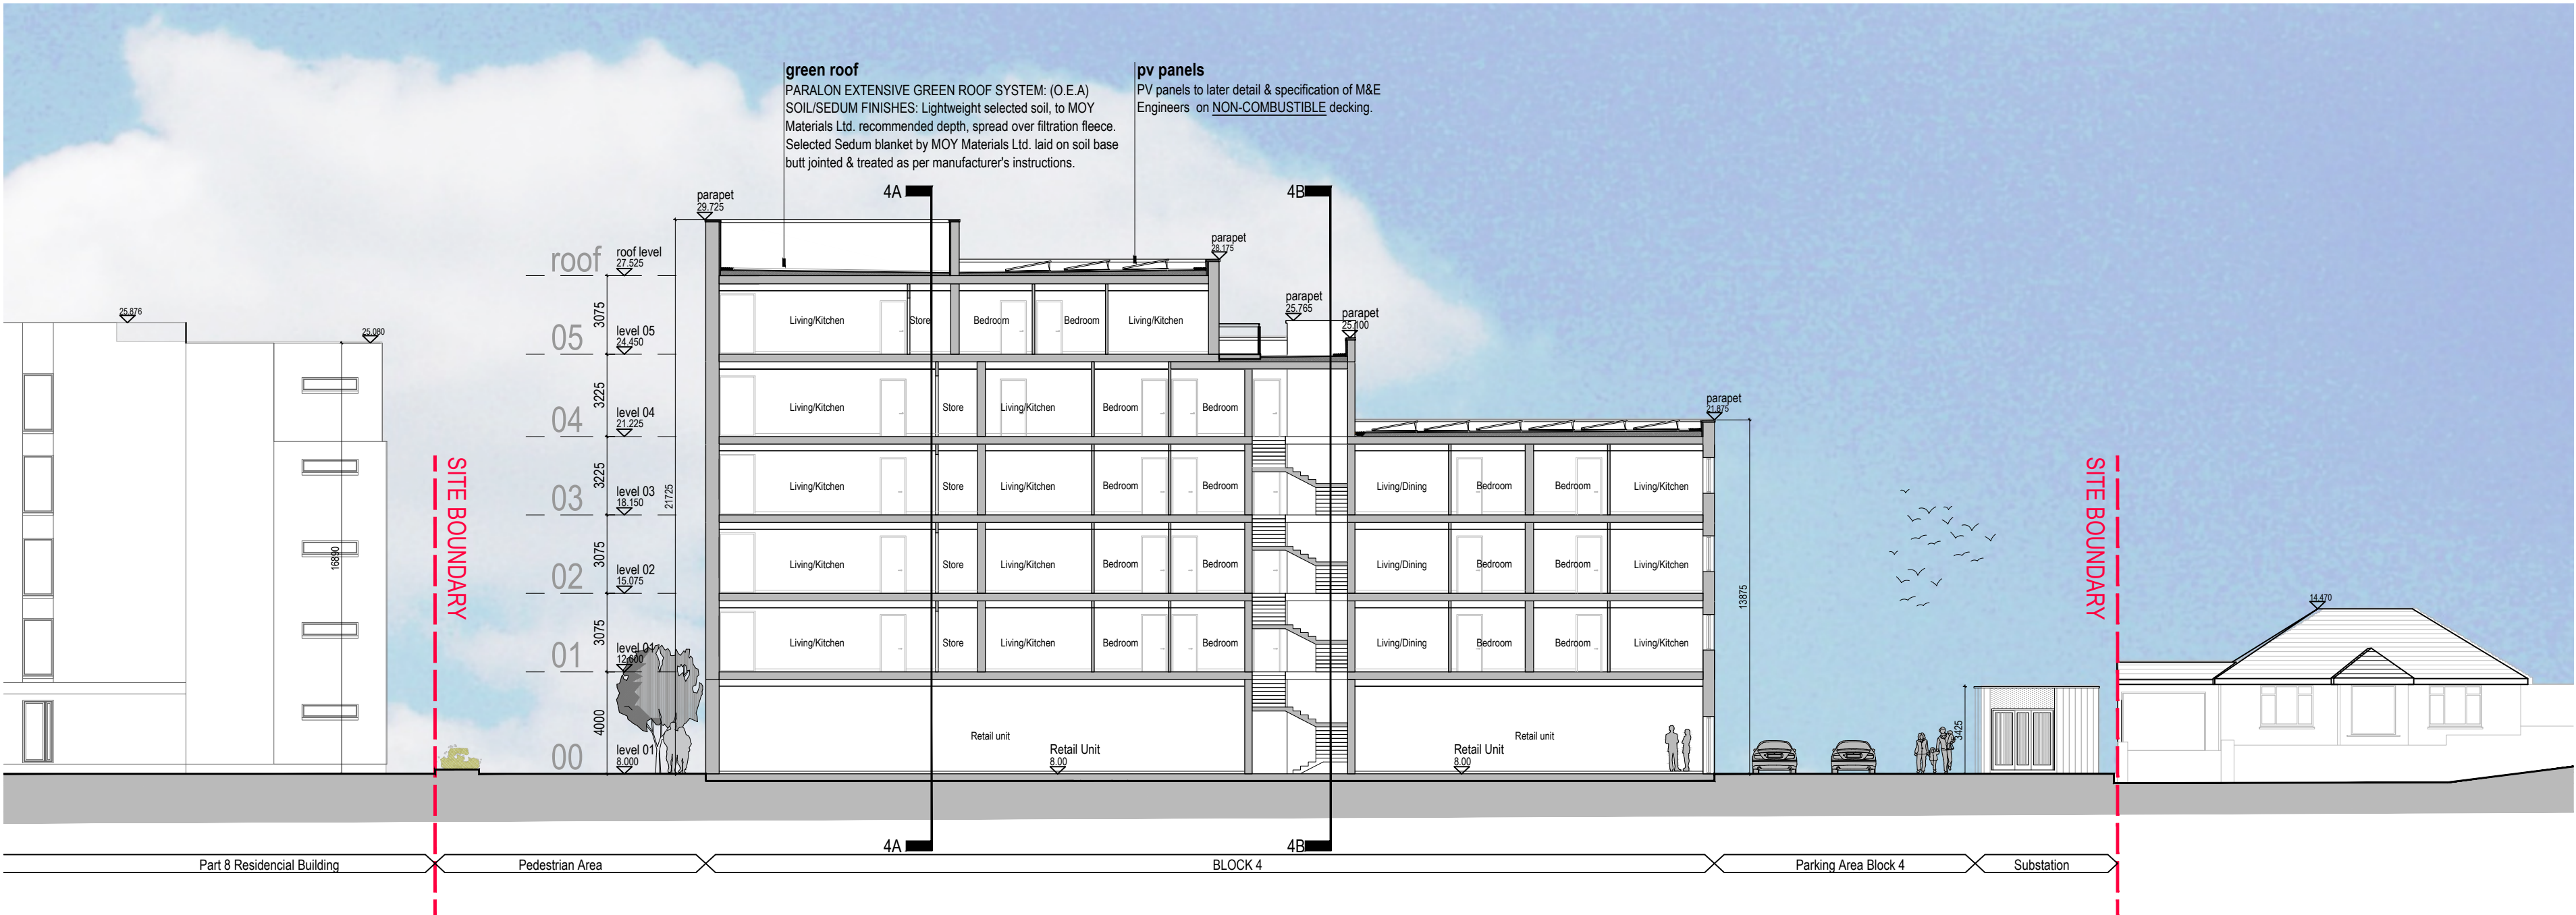

04 Block 4 SECTION 4-D
1:200



KEY PLAN 1:500

Block 4 Sections

Notes 1. Copyright Reserved 2. Work to figured dimensions only. Do not scale drawing. 3. The contractor is responsible for checking all levels and dimensions on site and shall refer all discrepancies to the Architect. 4. Where appropriate, for details of r.c. structure, or mechanical and electrical details, see Engineers drawings. 5. Proprietary items shall be fixed in strict accordance with manufacturers instructions. 6. Sizes of proprietary items shall be checked with manufacturer. 7. The contractor shall be responsible for the coordination of structure, finishes and services.		Issue Status Progress Planning Application Fire Cert Disability Cert Tender Construction As Built Information Only		No. E		Date 03.04.2025	Revision General update to Sections	Initials OK
Project Kinsale Road LRD		Drawing Title Block 4 Sections		Scale 1:200 @A1		Drawn AA	Appd MD	Date 25.08.24
Project Code 6284		job KRC	origin BKD	zone 04	level ZZ	type DR	ds A-	sheet no. 3001
		status P3.4		rev E				

bkdarchitects
B K E - K E N N E D Y D O Y L E
2ND FLOOR EUROPA HOUSE, MARCOURT CENTRE, MARCOURT ST, DUBLIN 02.
002 WRO, IRELAND - EMAIL: ARCHITECTURE@BKD.IE - PH: 01 618 2400 - W: WWW.BKD.IE