





01 CONTEXT ELEVATION A-A
1:500



02 CONTEXT ELEVATION B-B
1:500

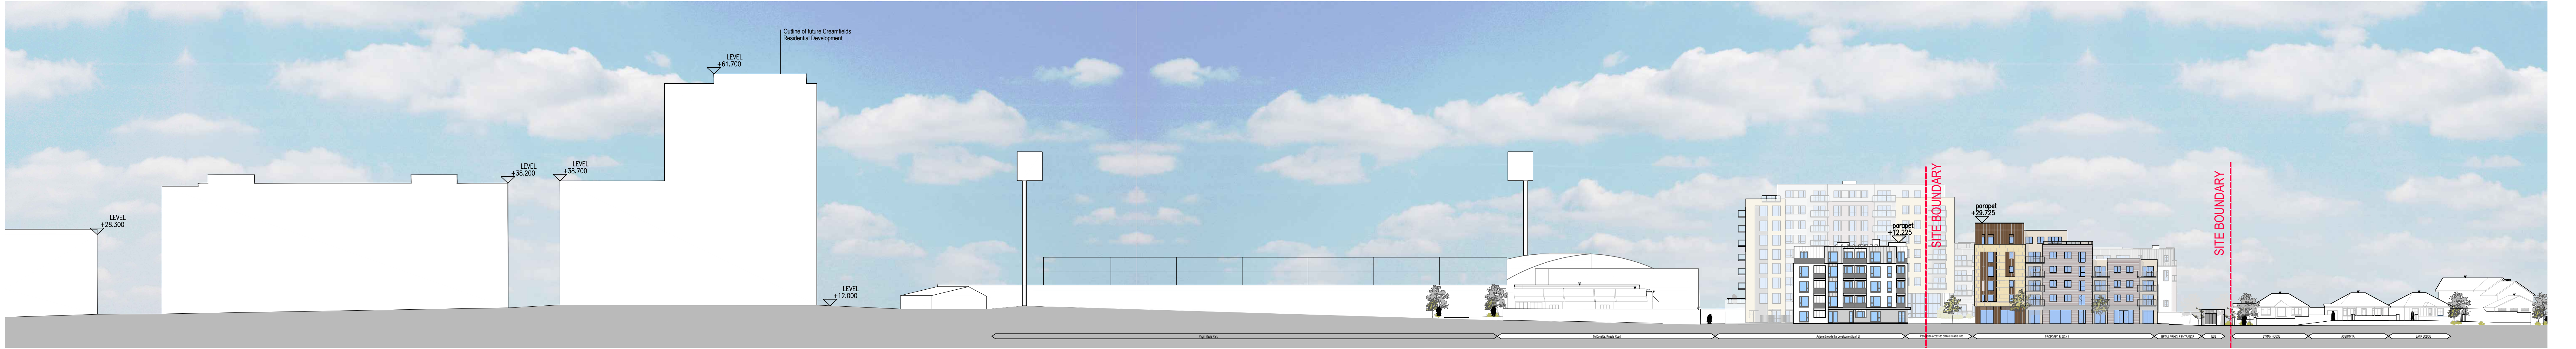

03 CONTEXT ELEVATION B-B
1:200

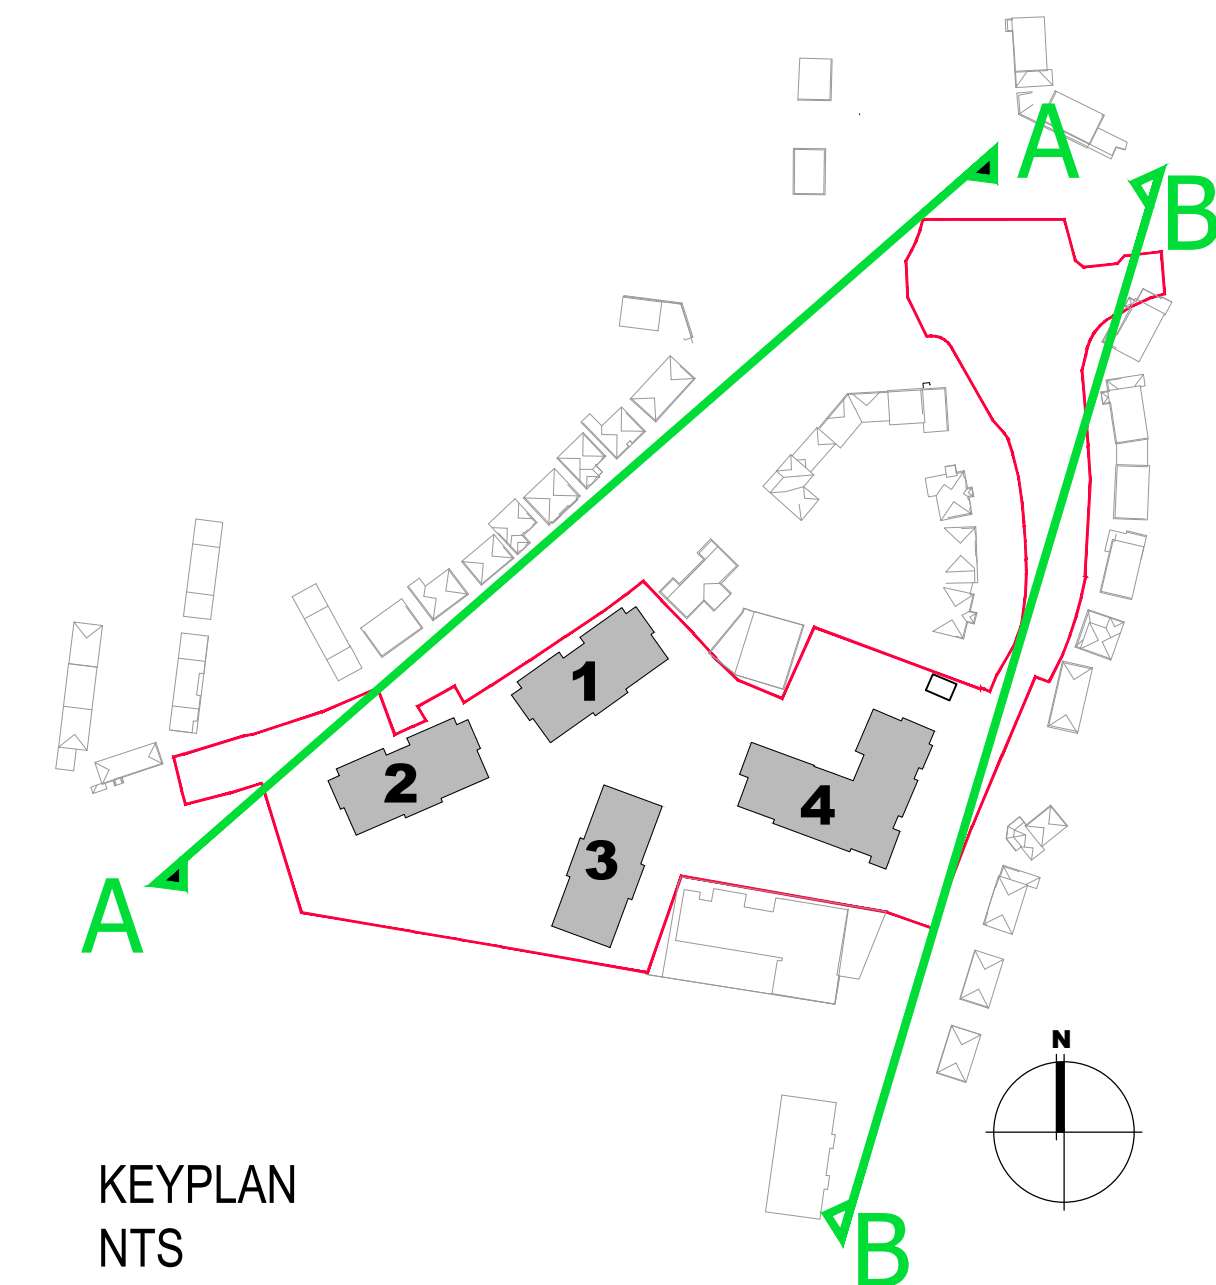

KEYPLAN
NTS

CONTEXTUAL SITE ELEVATIONS

Notes:		Issue Status		No.		Date		Revision		Initials	
1. Copyright Reserved		Programs		7		18.04.2025		General Update		DR	
2. Work to signed dimensions only. Do not scale drawings.		Planning Application									
3. The contractor is responsible for checking all levels and dimensions on site and shall refer all discrepancies to the Architect.		Fire Cert									
4. Where appropriate, for details of c., structure or mechanical and electrical details, see Engineers drawings.		Disability Cert									
5. Proprietary items shall be fixed in strict accordance with manufacturers instructions.		Tender									
6. Size of proprietary items shall be checked with manufacturer.		Construction									
7. The contractor shall be responsible for the coordination of structure, finishes and services.		As-Built									
Information Only		Information Only									

Project		Kinsale Road LRD		Drawing Title		Contextual Site Elevations		Scale		1:500 & 1:200 @ A0		Version		DR		Date		03.09.2024	
Stage		Planning		Job		KRD		Zone		BKD		Level		ZZ		DR		A-	
Project Code		6284		Year		2020		Sheet no.		P3.4		Rev		F					

bkdarchitects

Architects