




BIN STORE & BIKE STATION 1 - 52 Bikes

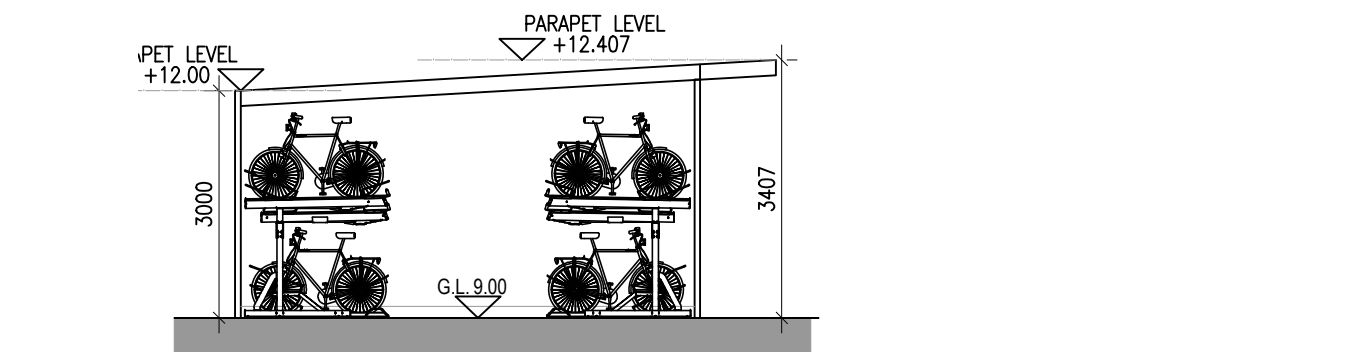

1 BIKE STATION AND BIN STORE NORTH SECTION  
1:100

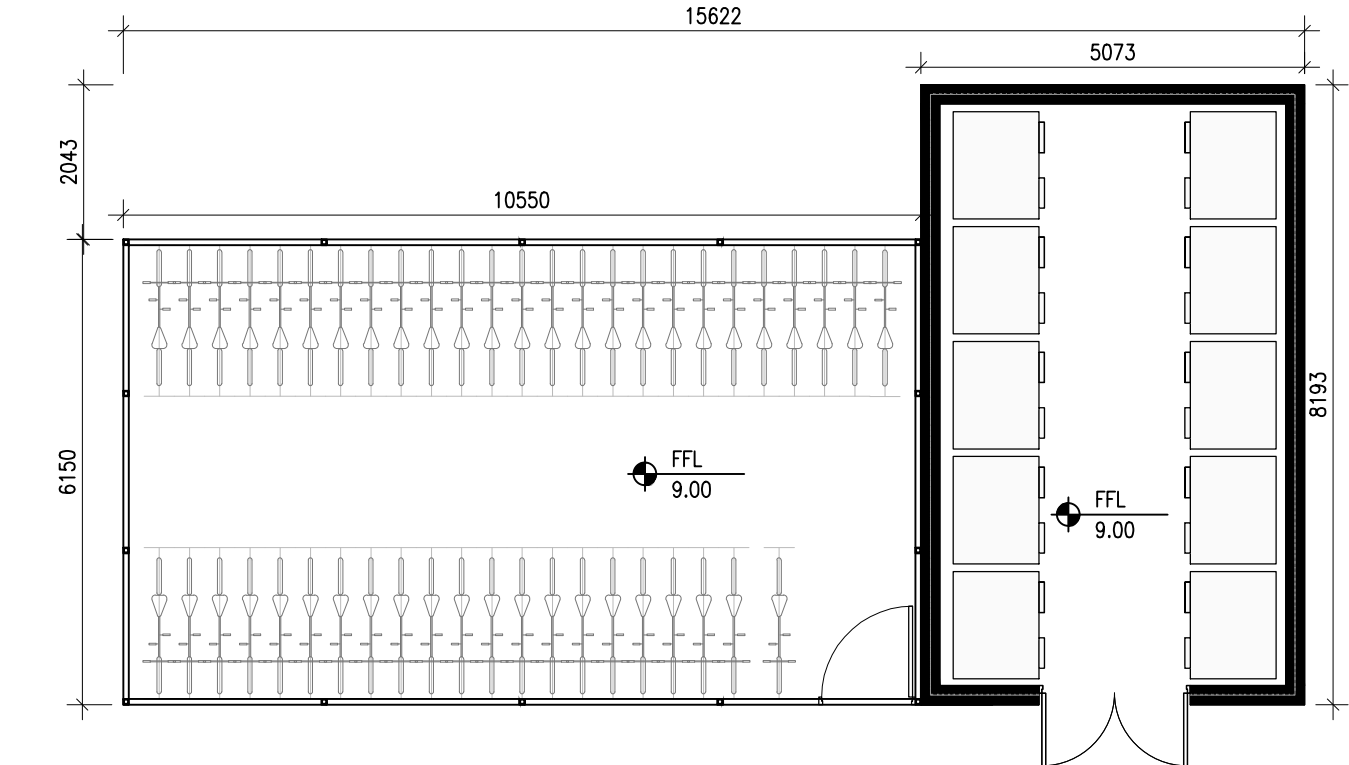


3 BIKE STATION & BIN STORE FLOOR PLAN  
1:100

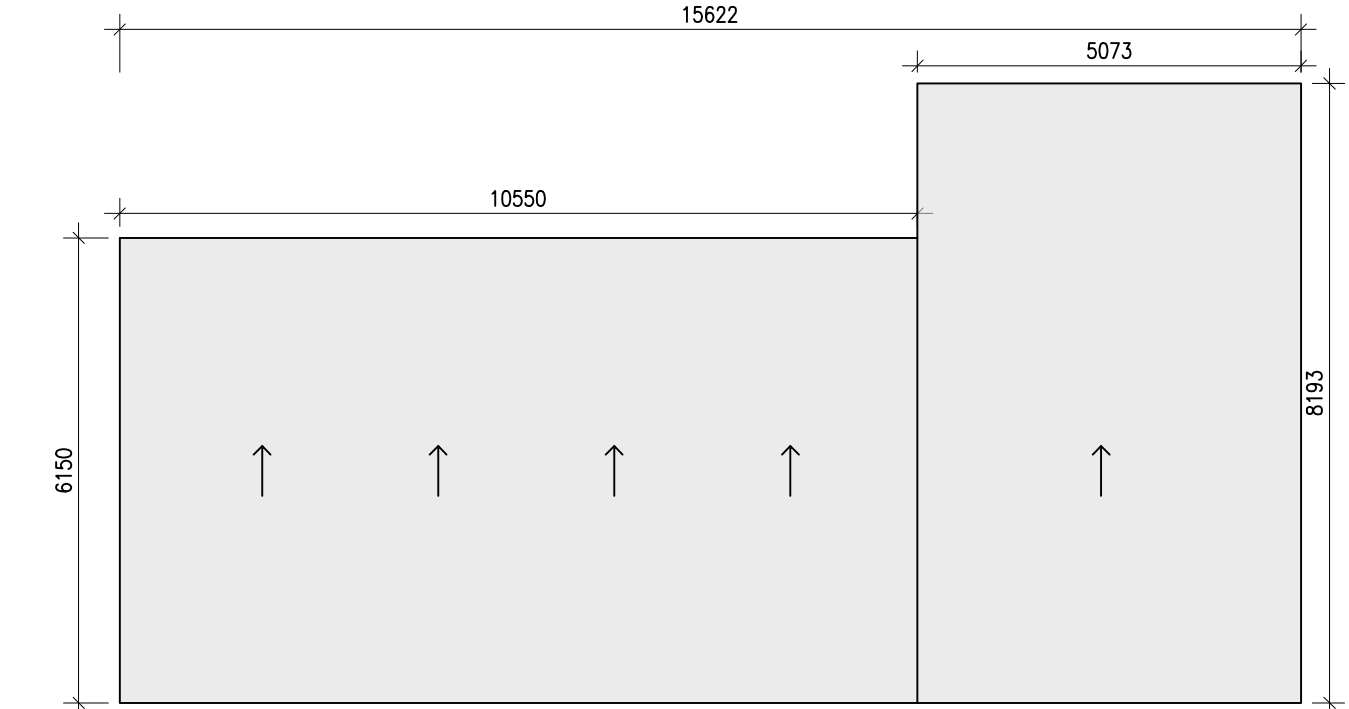


5 BIKE STATION & BIN STORE FLOOR PLAN  
1:100

ESB SUBSTATION

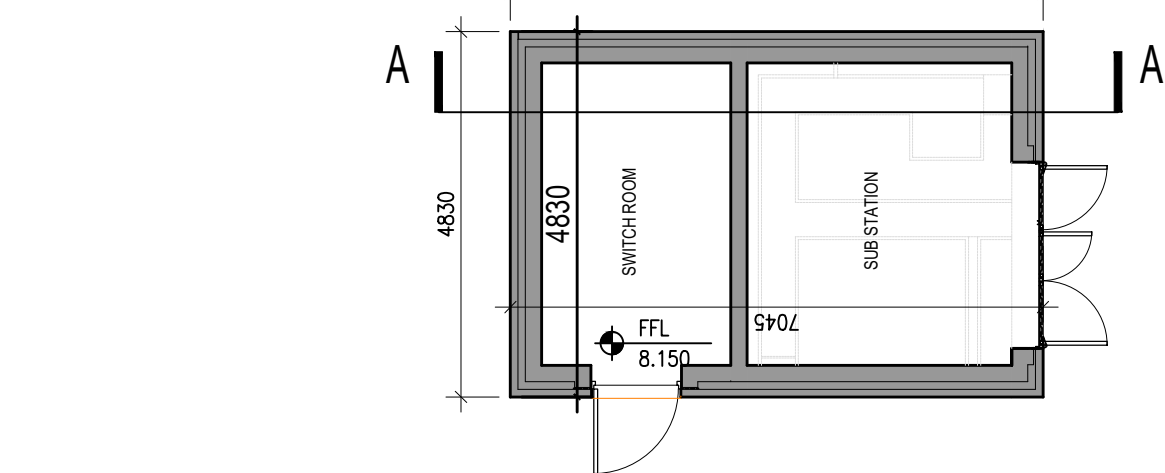

5 ESB SUBSTATION FLOOR PLAN  
1:100

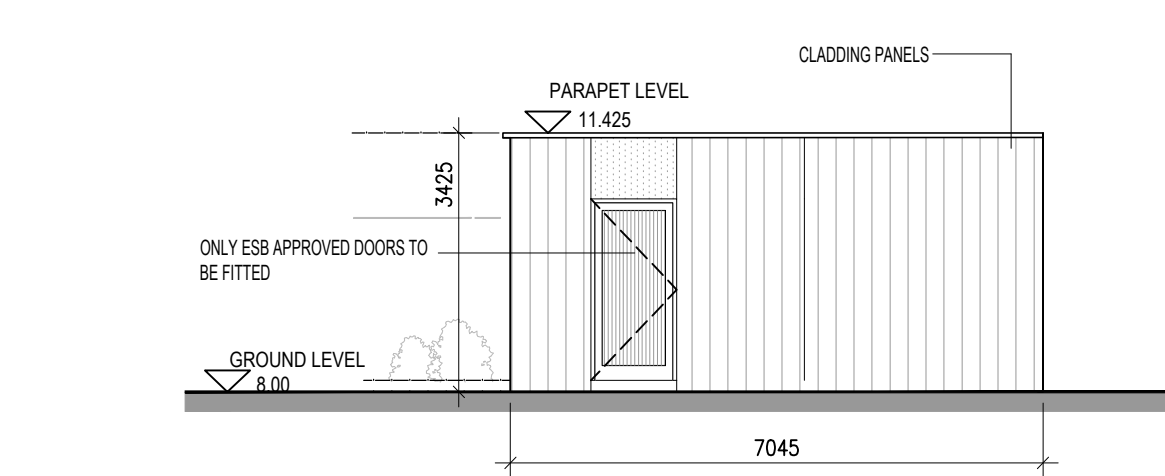


8 ESB SUBSTATION NORTH ELEVATION  
1:100


Notes	Issue Status
1. Copyright Reserved	Progress
2. Work to figure dimensions only. Do not scale drawing.	Planning Application
3. The contractor is responsible for checking all levels and dimensions on site and shall refer all discrepancies to the Architect.	Fire Cert
4. Where appropriate, for details of r.c. structure, or mechanical and electrical details, see Engineers drawings.	Disability Cert
5. Proprietary items shall be fixed in strict accordance with manufacturers instructions.	Tender
6. Sizes of proprietary items shall be checked with manufacturer.	Construction
7. The contractor shall be responsible for the coordination of structure, finishes and services.	As Built
	Information Only

M:\Project Section - Current\6284 Kinsale Road\CAD\Planning\Planning 1\15 LRD Planning Application\2\ CAD Drawings\5\ Details\6284\_KRC-BKD-ZZ-ZZ-DR-A-1200 (bins-bikes-ESB).dwg 08/04/2024 13:02:08


BIN STORE & BIKE STATION 2- 90 Bikes

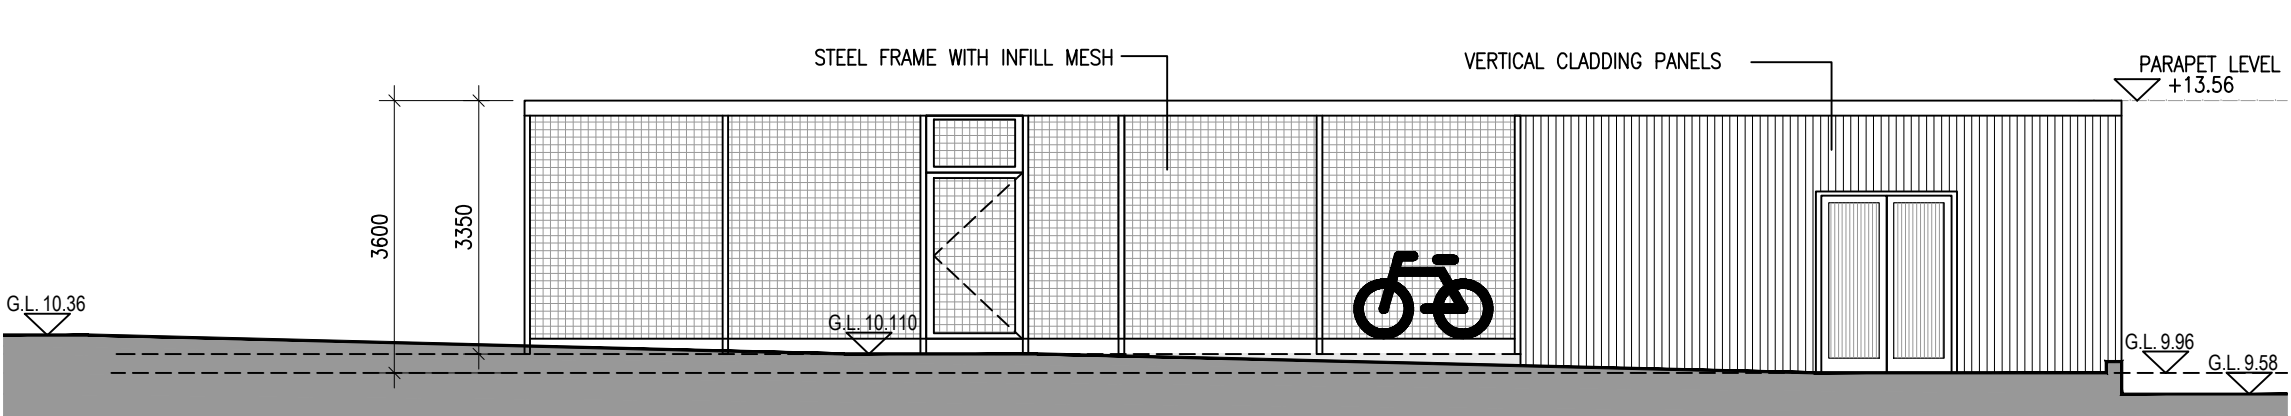

11 BIN STORE & BIKE STATION SOUTH WEST FACING ELEVATION  
1:100

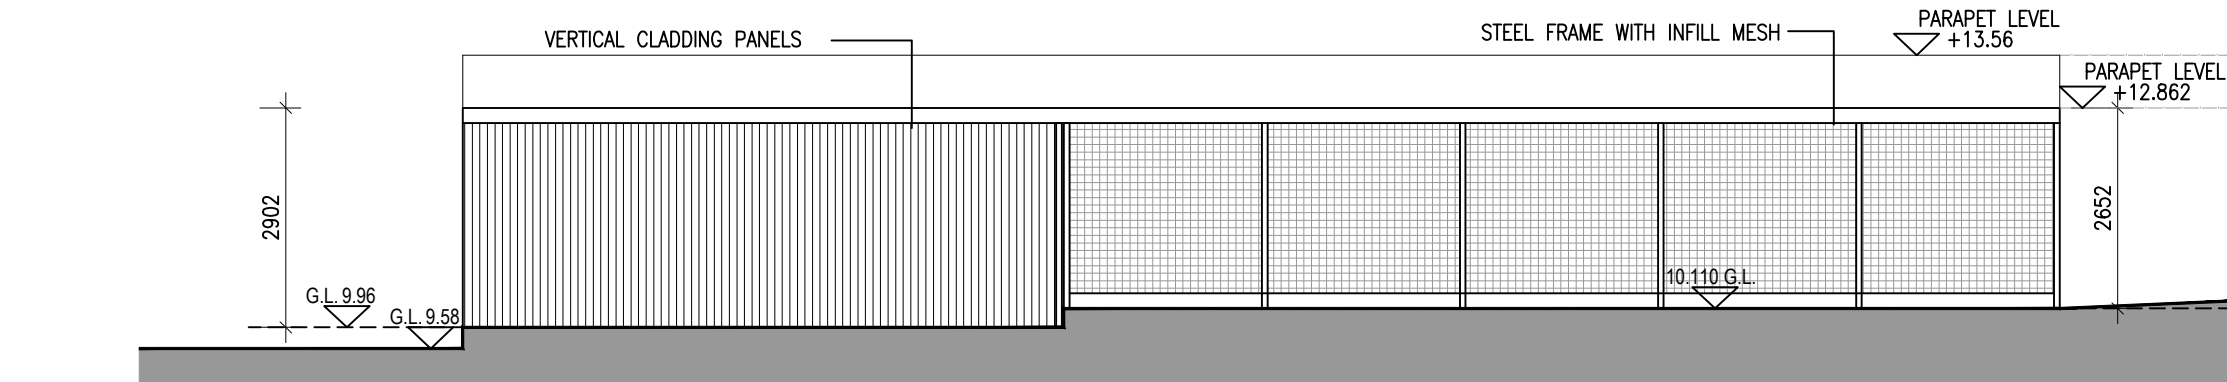


12 BIN STORE & BIKE STATION NORTH EAST FACING ELEVATION  
1:100

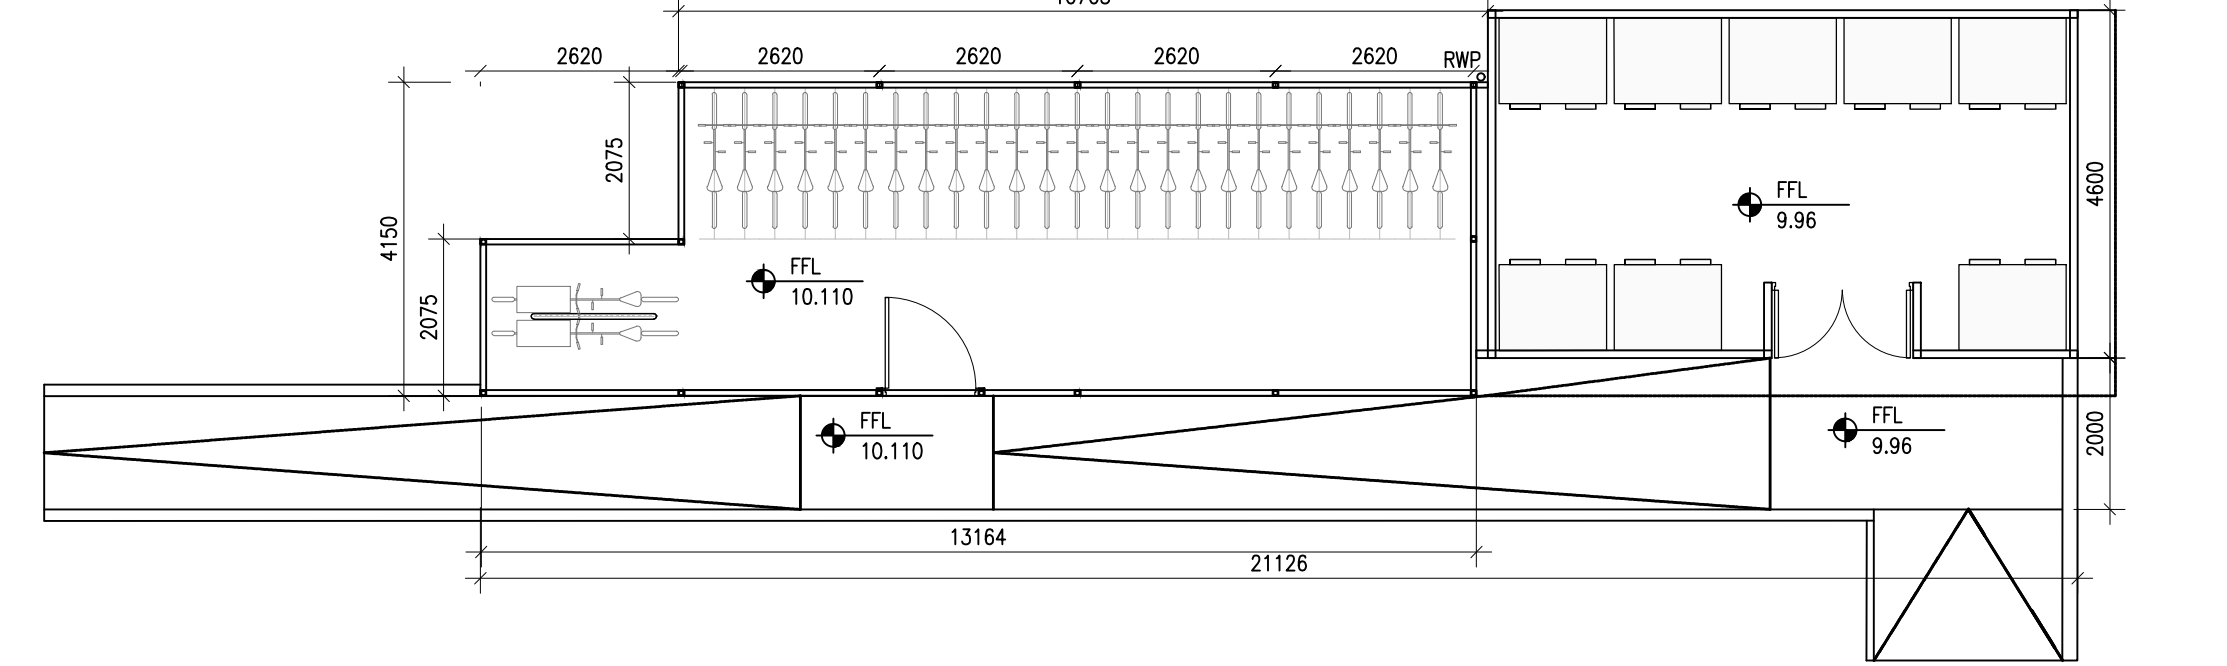


13 BIN STORE & BIKE STATION FLOOR PLAN  
1:100




14 BIN STORE & BIKE STATION ROOF PLAN  
1:100

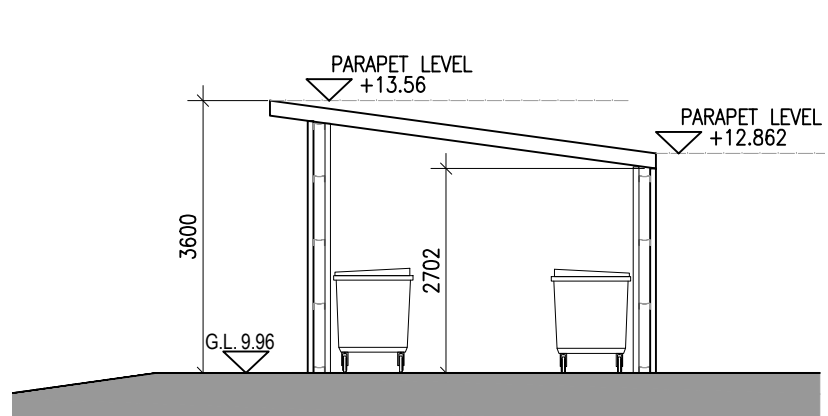


14 BIN STORE WEST SECTION  
1:100

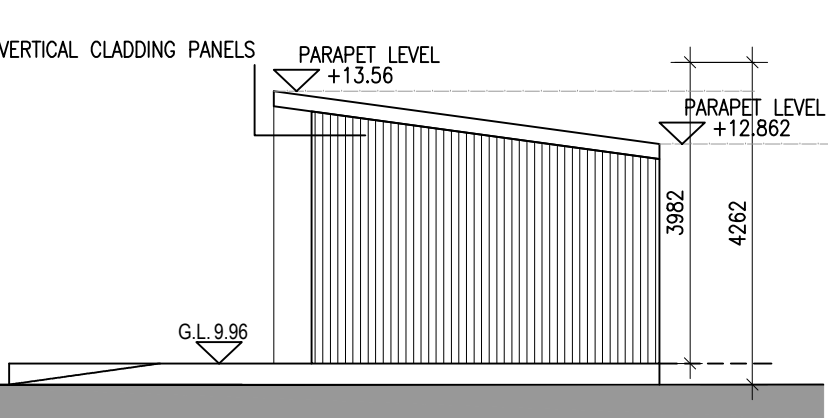

15 BIN STORE WEST ELEVATION  
1:100

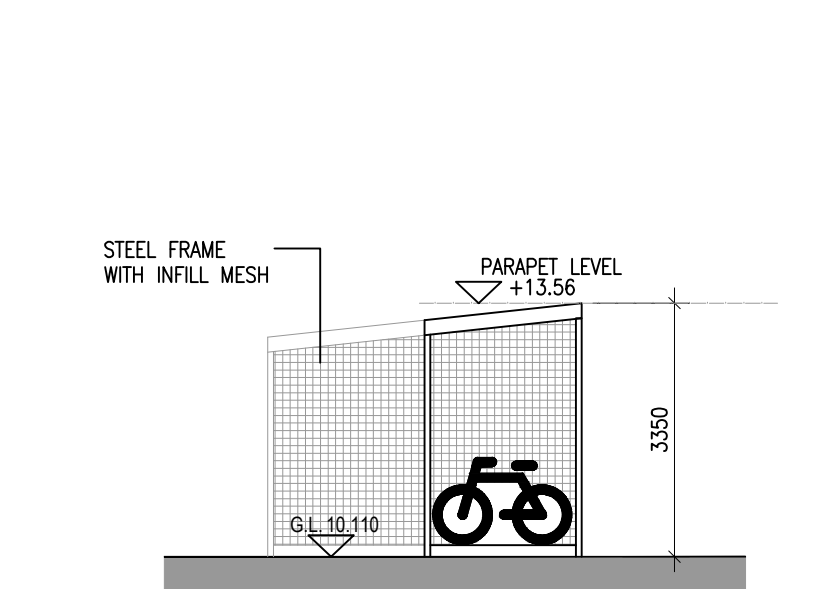


16 BIKE STATION EAST ELEVATION  
1:100

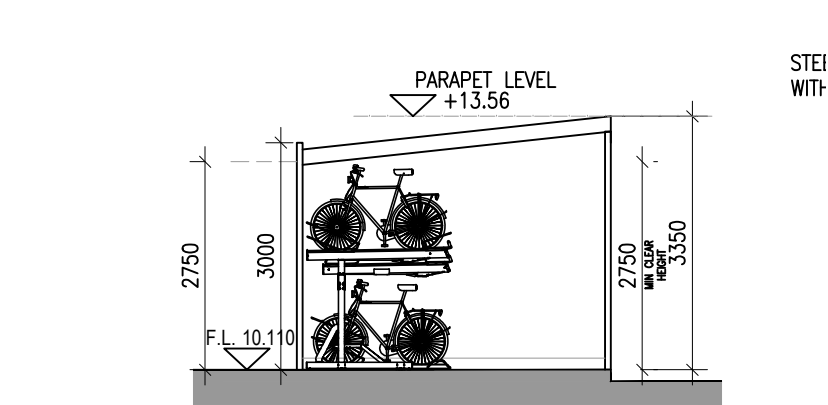

17 BIKE STATION EAST SECTION  
1:100

6 ESB SUBSTATION SOUTH SECTION A-A  
1:100

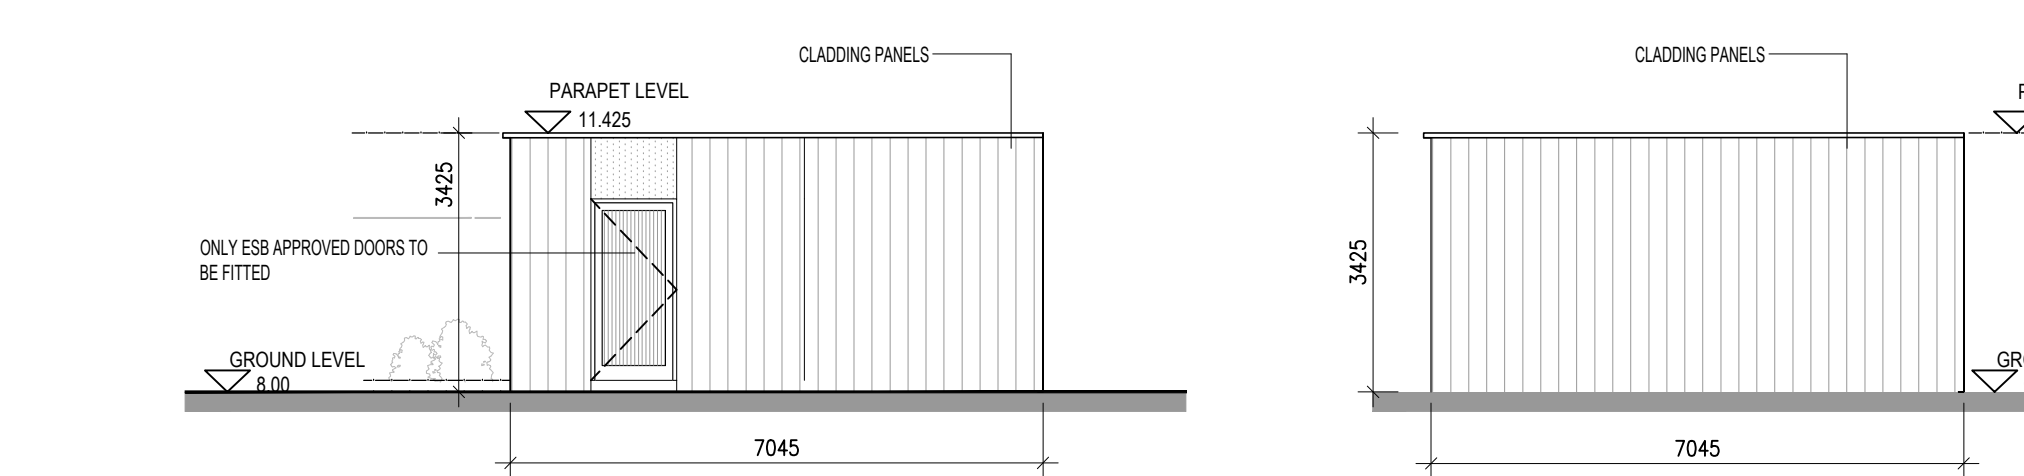


9 ESB SUBSTATION SOUTH ELEVATION  
1:100

Notes	Issue Status
1. Copyright Reserved	Progress
2. Work to figure dimensions only. Do not scale drawing.	Planning Application
3. The contractor is responsible for checking all levels and dimensions on site and shall refer all discrepancies to the Architect.	Fire Cert
4. Where appropriate, for details of r.c. structure, or mechanical and electrical details, see Engineers drawings.	Disability Cert
5. Proprietary items shall be fixed in strict accordance with manufacturers instructions.	Tender
6. Sizes of proprietary items shall be checked with manufacturer.	Construction
7. The contractor shall be responsible for the coordination of structure, finishes and services.	As Built
	Information Only

M:\Project Section - Current\6284 Kinsale Road\CAD\Planning\Planning 1\15 LRD Planning Application\2\ CAD Drawings\5\ Details\6284\_KRC-BKD-ZZ-ZZ-DR-A-1200 (bins-bikes-ESB).dwg 08/04/2024 13:02:08

7 ESB SUBSTATION EAST ELEVATION  
1:100

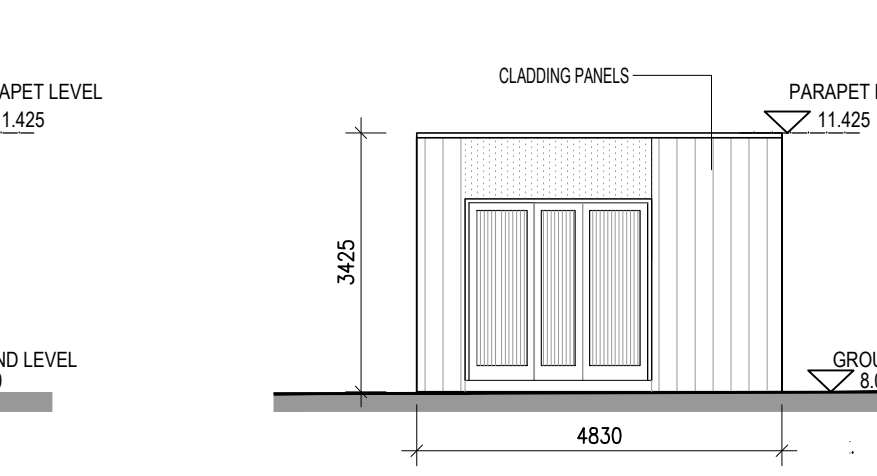


10 ESB SUBSTATION WEST ELEVATION  
1:100

Notes	Issue Status
1. Copyright Reserved	Progress
2. Work to figure dimensions only. Do not scale drawing.	Planning Application
3. The contractor is responsible for checking all levels and dimensions on site and shall refer all discrepancies to the Architect.	Fire Cert
4. Where appropriate, for details of r.c. structure, or mechanical and electrical details, see Engineers drawings.	Disability Cert
5. Proprietary items shall be fixed in strict accordance with manufacturers instructions.	Tender
6. Sizes of proprietary items shall be checked with manufacturer.	Construction
7. The contractor shall be responsible for the coordination of structure, finishes and services.	As Built
	Information Only

M:\Project Section - Current\6284 Kinsale Road\CAD\Planning\Planning 1\15 LRD Planning Application\2\ CAD Drawings\5\ Details\6284\_KRC-BKD-ZZ-ZZ-DR-A-1200 (bins-bikes-ESB).dwg 08/04/2024 13:02:08

- SITE BOUNDARY
- BIN STORE & BIKE STATION 2
- BIN STORE & BIKE STATION 1
- ESB SUBSTATION

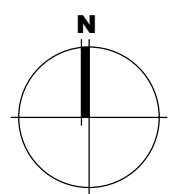

No.	Date	Revision	Initials
D	03.04.2025	General Update to Drawings	DK

Project	Kinale Road LRD
Drawing Title	ESB SUBSTATION, BIN STORES AND BIKE STATIONS
Stage	Planning
Scale	1:100@A1
Drawn	DK
Appd	MD
Date	27.08.2024
Project Code	6284
job	KRC
origin	BKD
zone	ZZ
level	ZZ
type	DR
dis	A-
sheet no.	1200
status	P3.4
rev	D

**bkd**architects  
2ND FLOOR EUROPA HOUSE, HARCOURT CENTRE, HARCOURT ST. DUBLIN D2.  
002 WRO. IRELAND - EMAIL:ARCHITECTURE@BKD.IE - PH:01 616 5800 - W: WWW.BKD.IE